


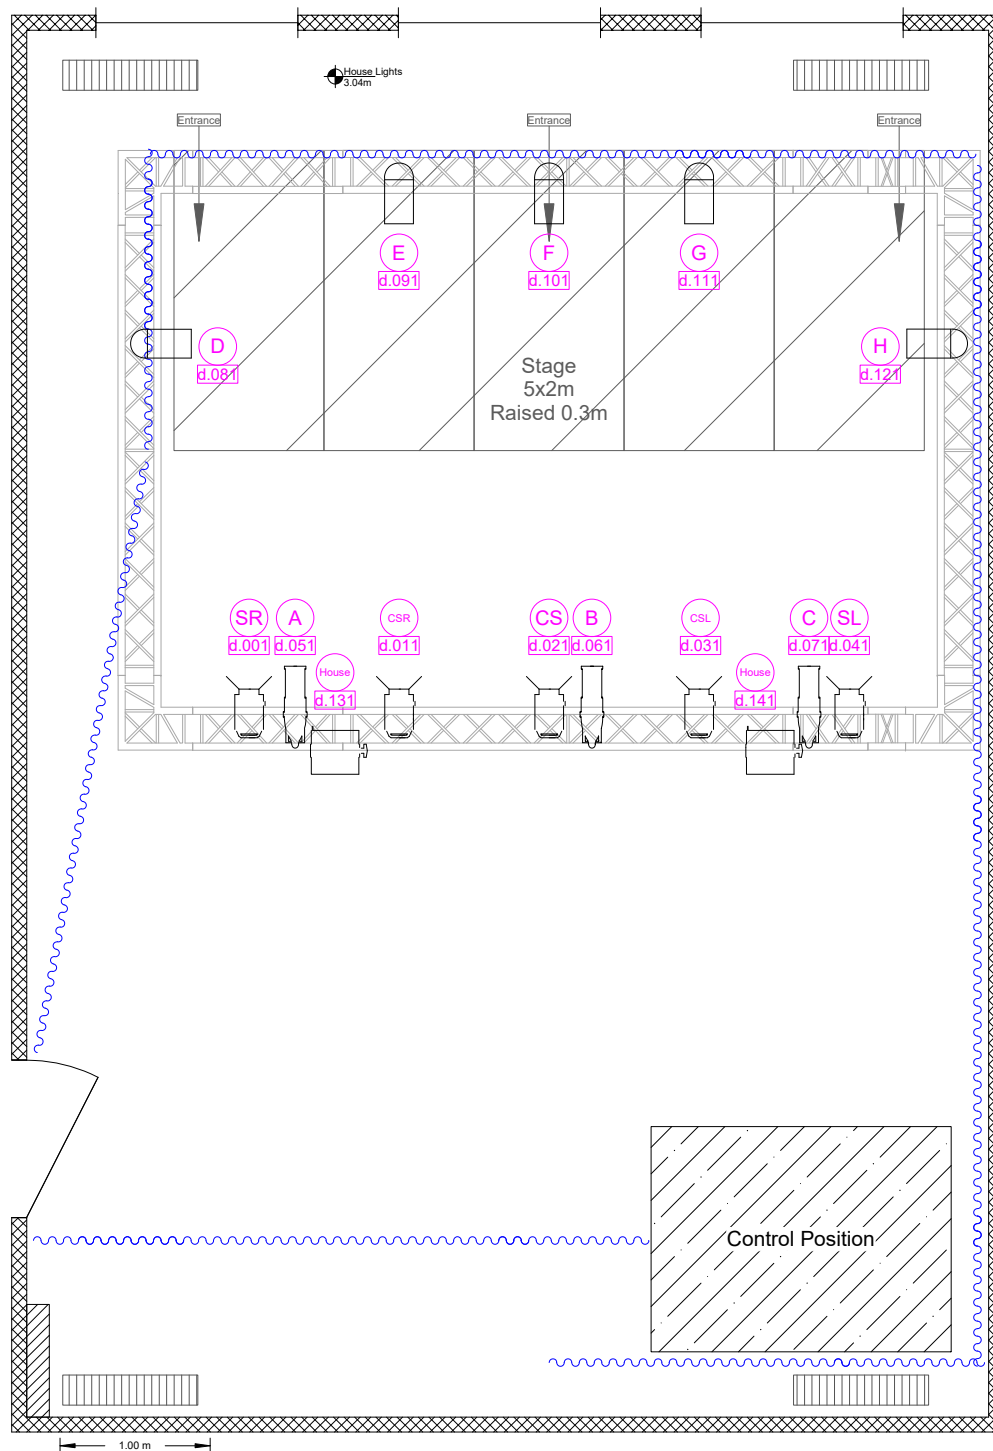

	Chauvet Colordash Par-H12 IP Mode: 8ch P 5p
	ETC ColorSource Fresnel V Mode: STD (7ch) T 5p
	ETC ColorSource Spot Jr 25-50 Mode: SCH (5ch) P 5p
	Showtec Cameleon Flood 15 Q4 Mode: 4ch T 3p
	Fixture Number DMX Address

VENUE theSpace @ Surgeons' Hall			
TITLE Stephenson Theatre LIGHTING Plan			
SIZE A4	CAGE CODE	DWG NO theSpaceUK-VP-32-18	REV 25.1
SCALE			SHEET