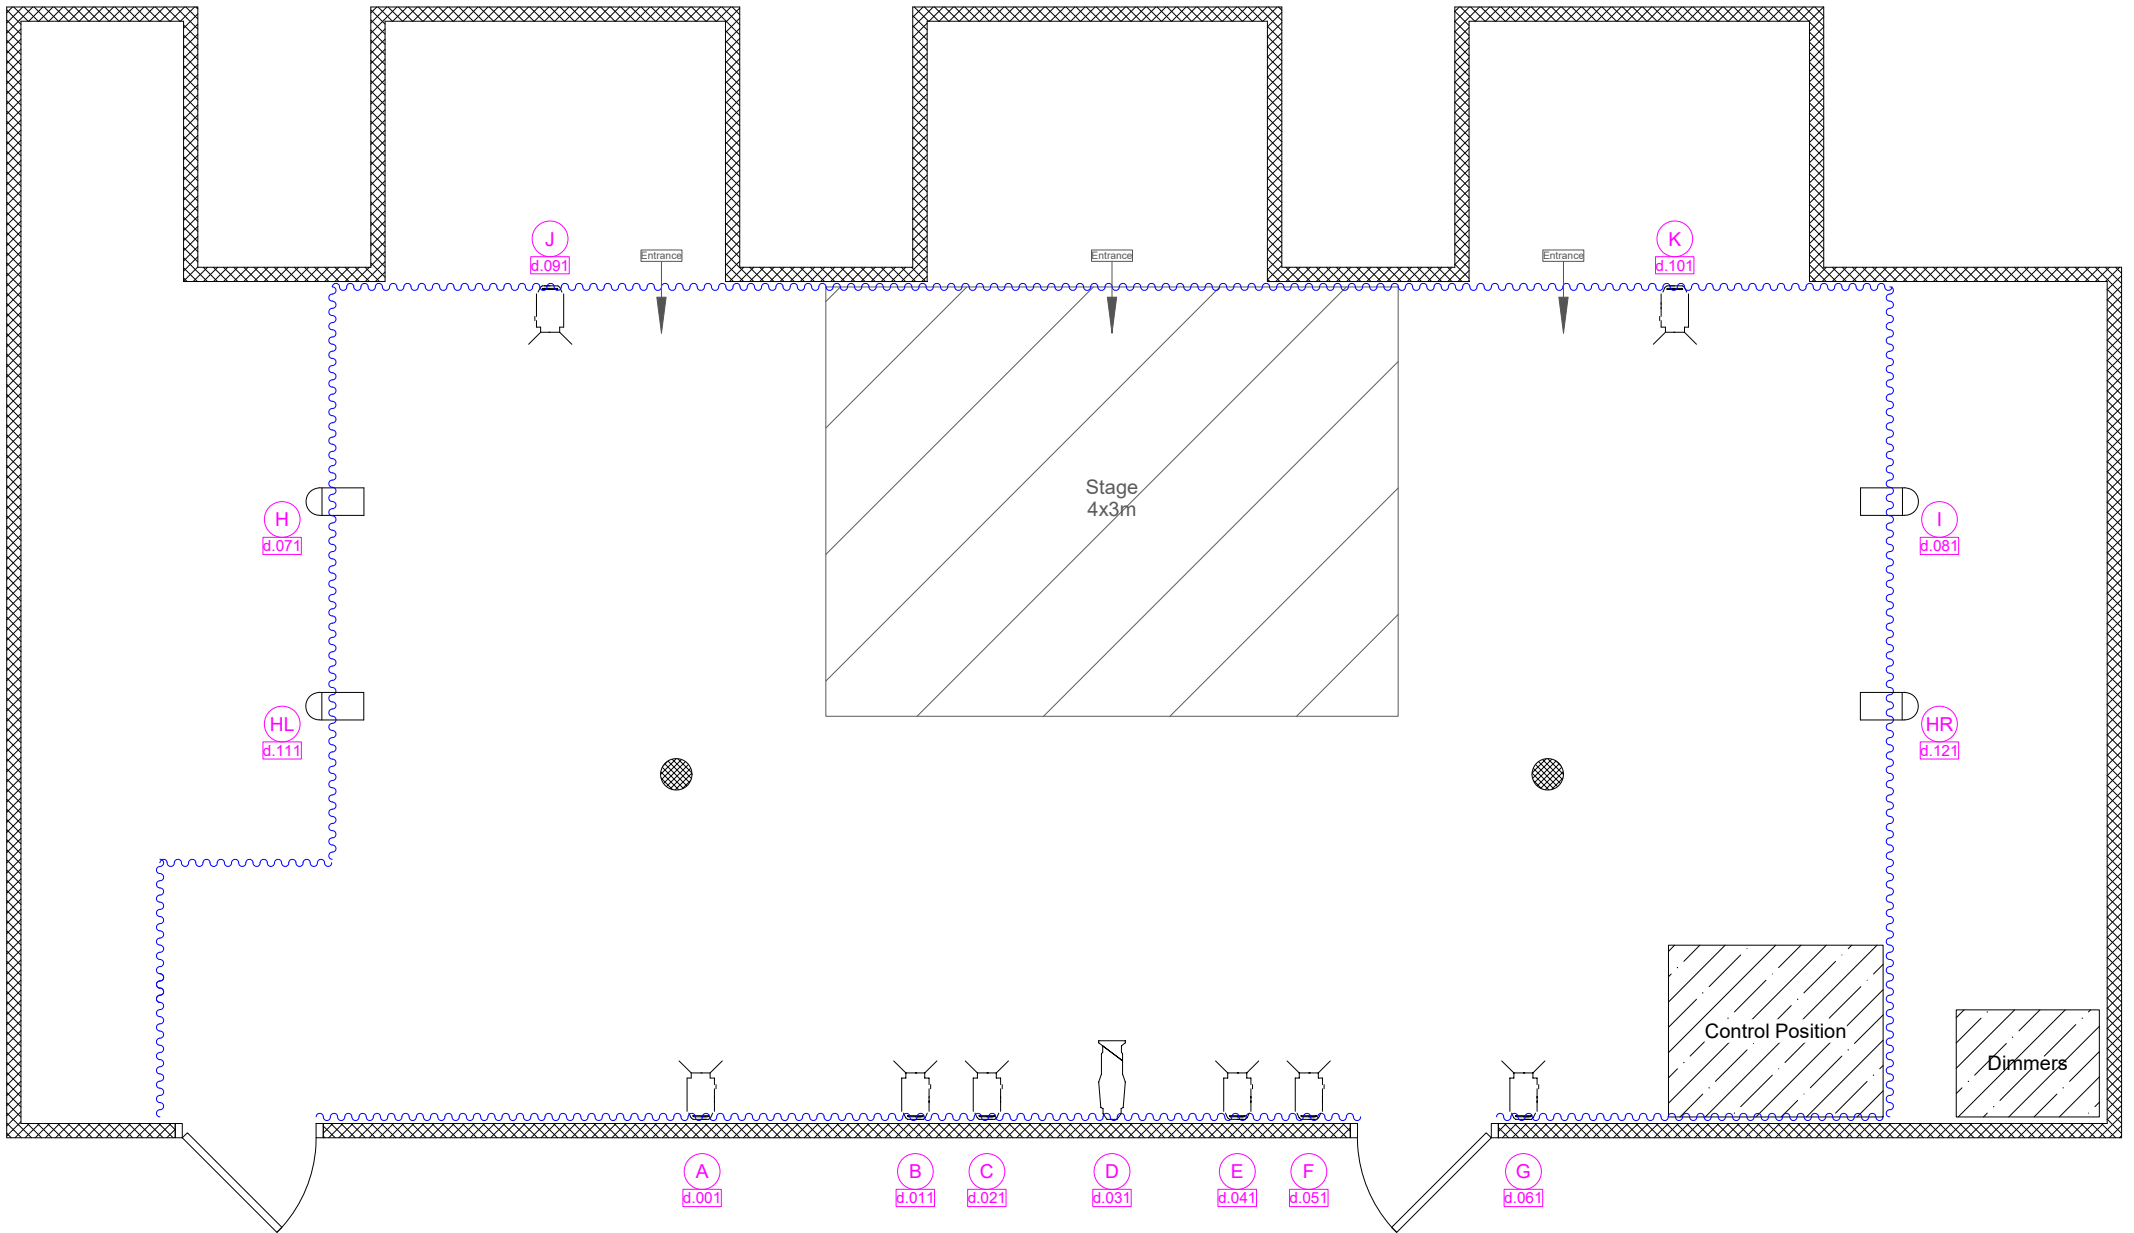


 



1.00 m



	<b>Cameo Root Par 6</b> Mode: 6ch P 3p
	<b>Cameo F1 FC LED Fresnel RGBW</b> Mode: 4ch T 5p
	<b>ETC ColorSource Spot Jr 25-50</b> Mode: 5CH (5ch) P 5p
	<b>Fixture Number DMX Address</b>

VENUE		theSpace Triplex	
TITLE		Studio Theatre LIGHTING Plan	
SIZE	CAGE CODE	DWG NO	REV
A4		theSpaceUK-VP-18-18	25.1
SCALE		SHEET	