
 


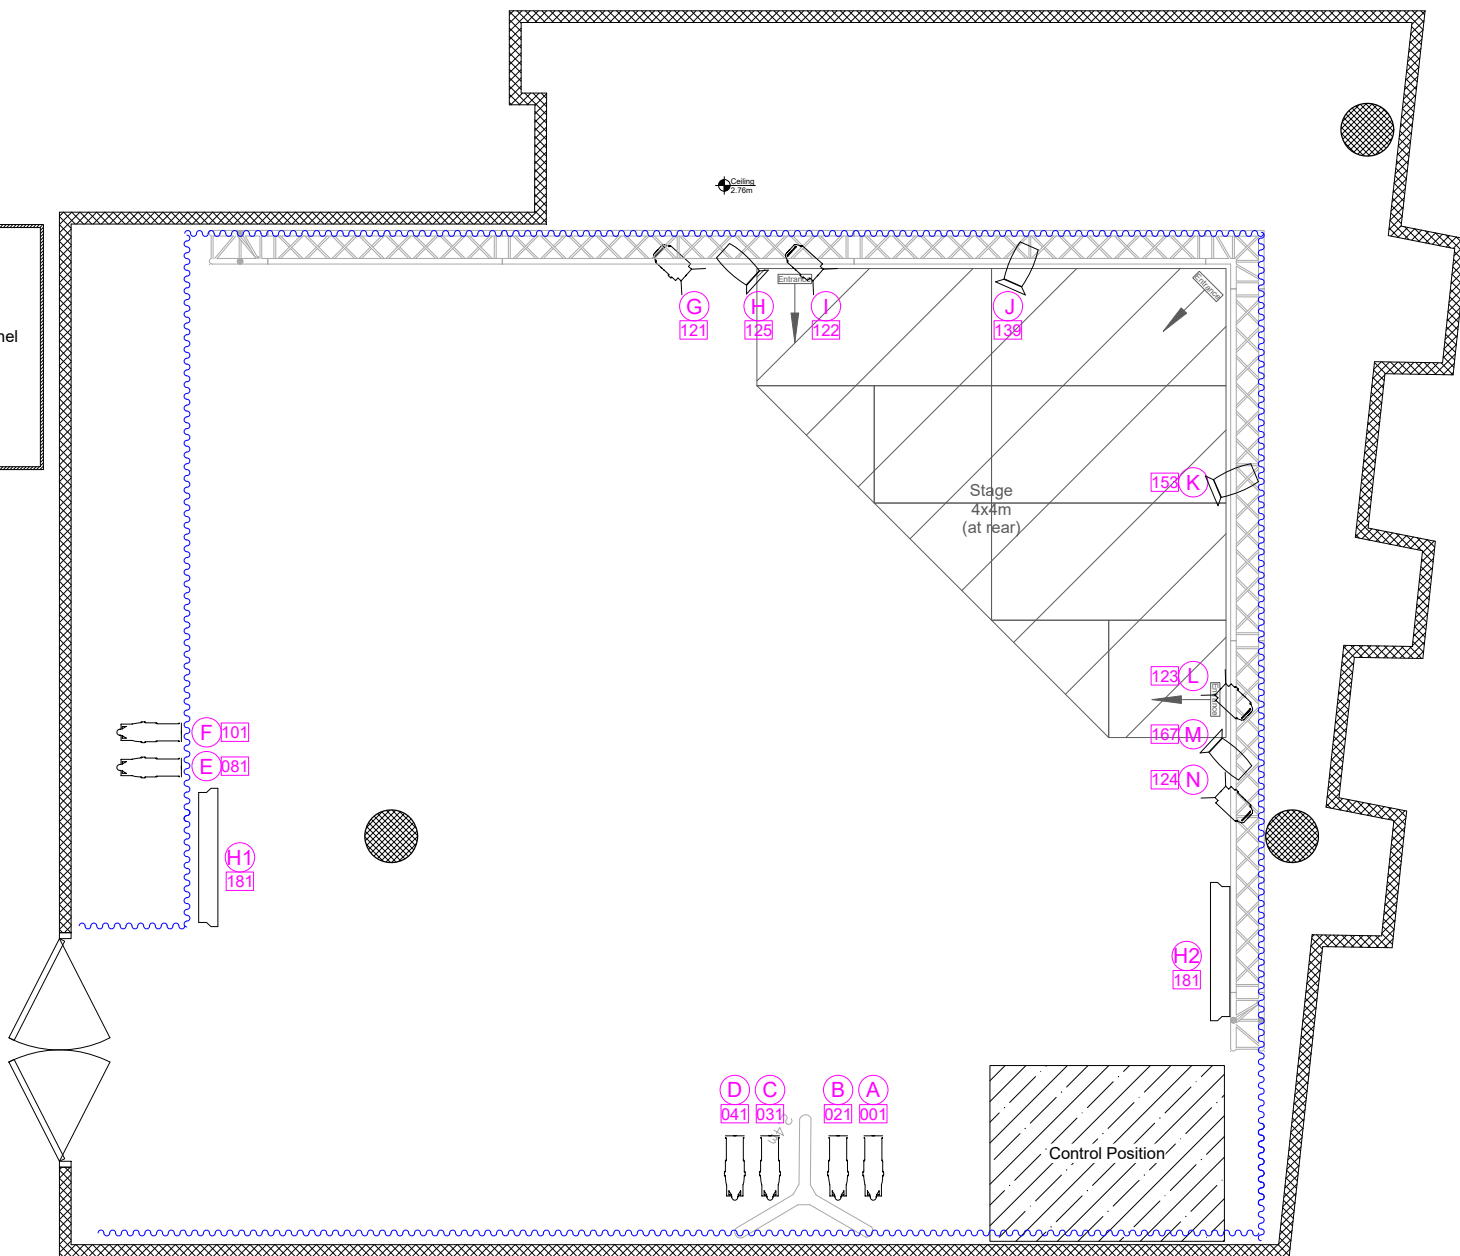
	Robe Perfect
	LED Profile
	Elumen8 LED Fresnel
	PixelLine
	Fixture Number DMX Address



1.00 m

VENUE		theSpace @ Surgeons' Hall	
TITLE		Theatre 1 LIGHTING Plan	
SIZE	CAGE CODE	DWG NO	REV
A4		theSpaceUK-VP-06-18	25.1
SCALE		SHEET	